


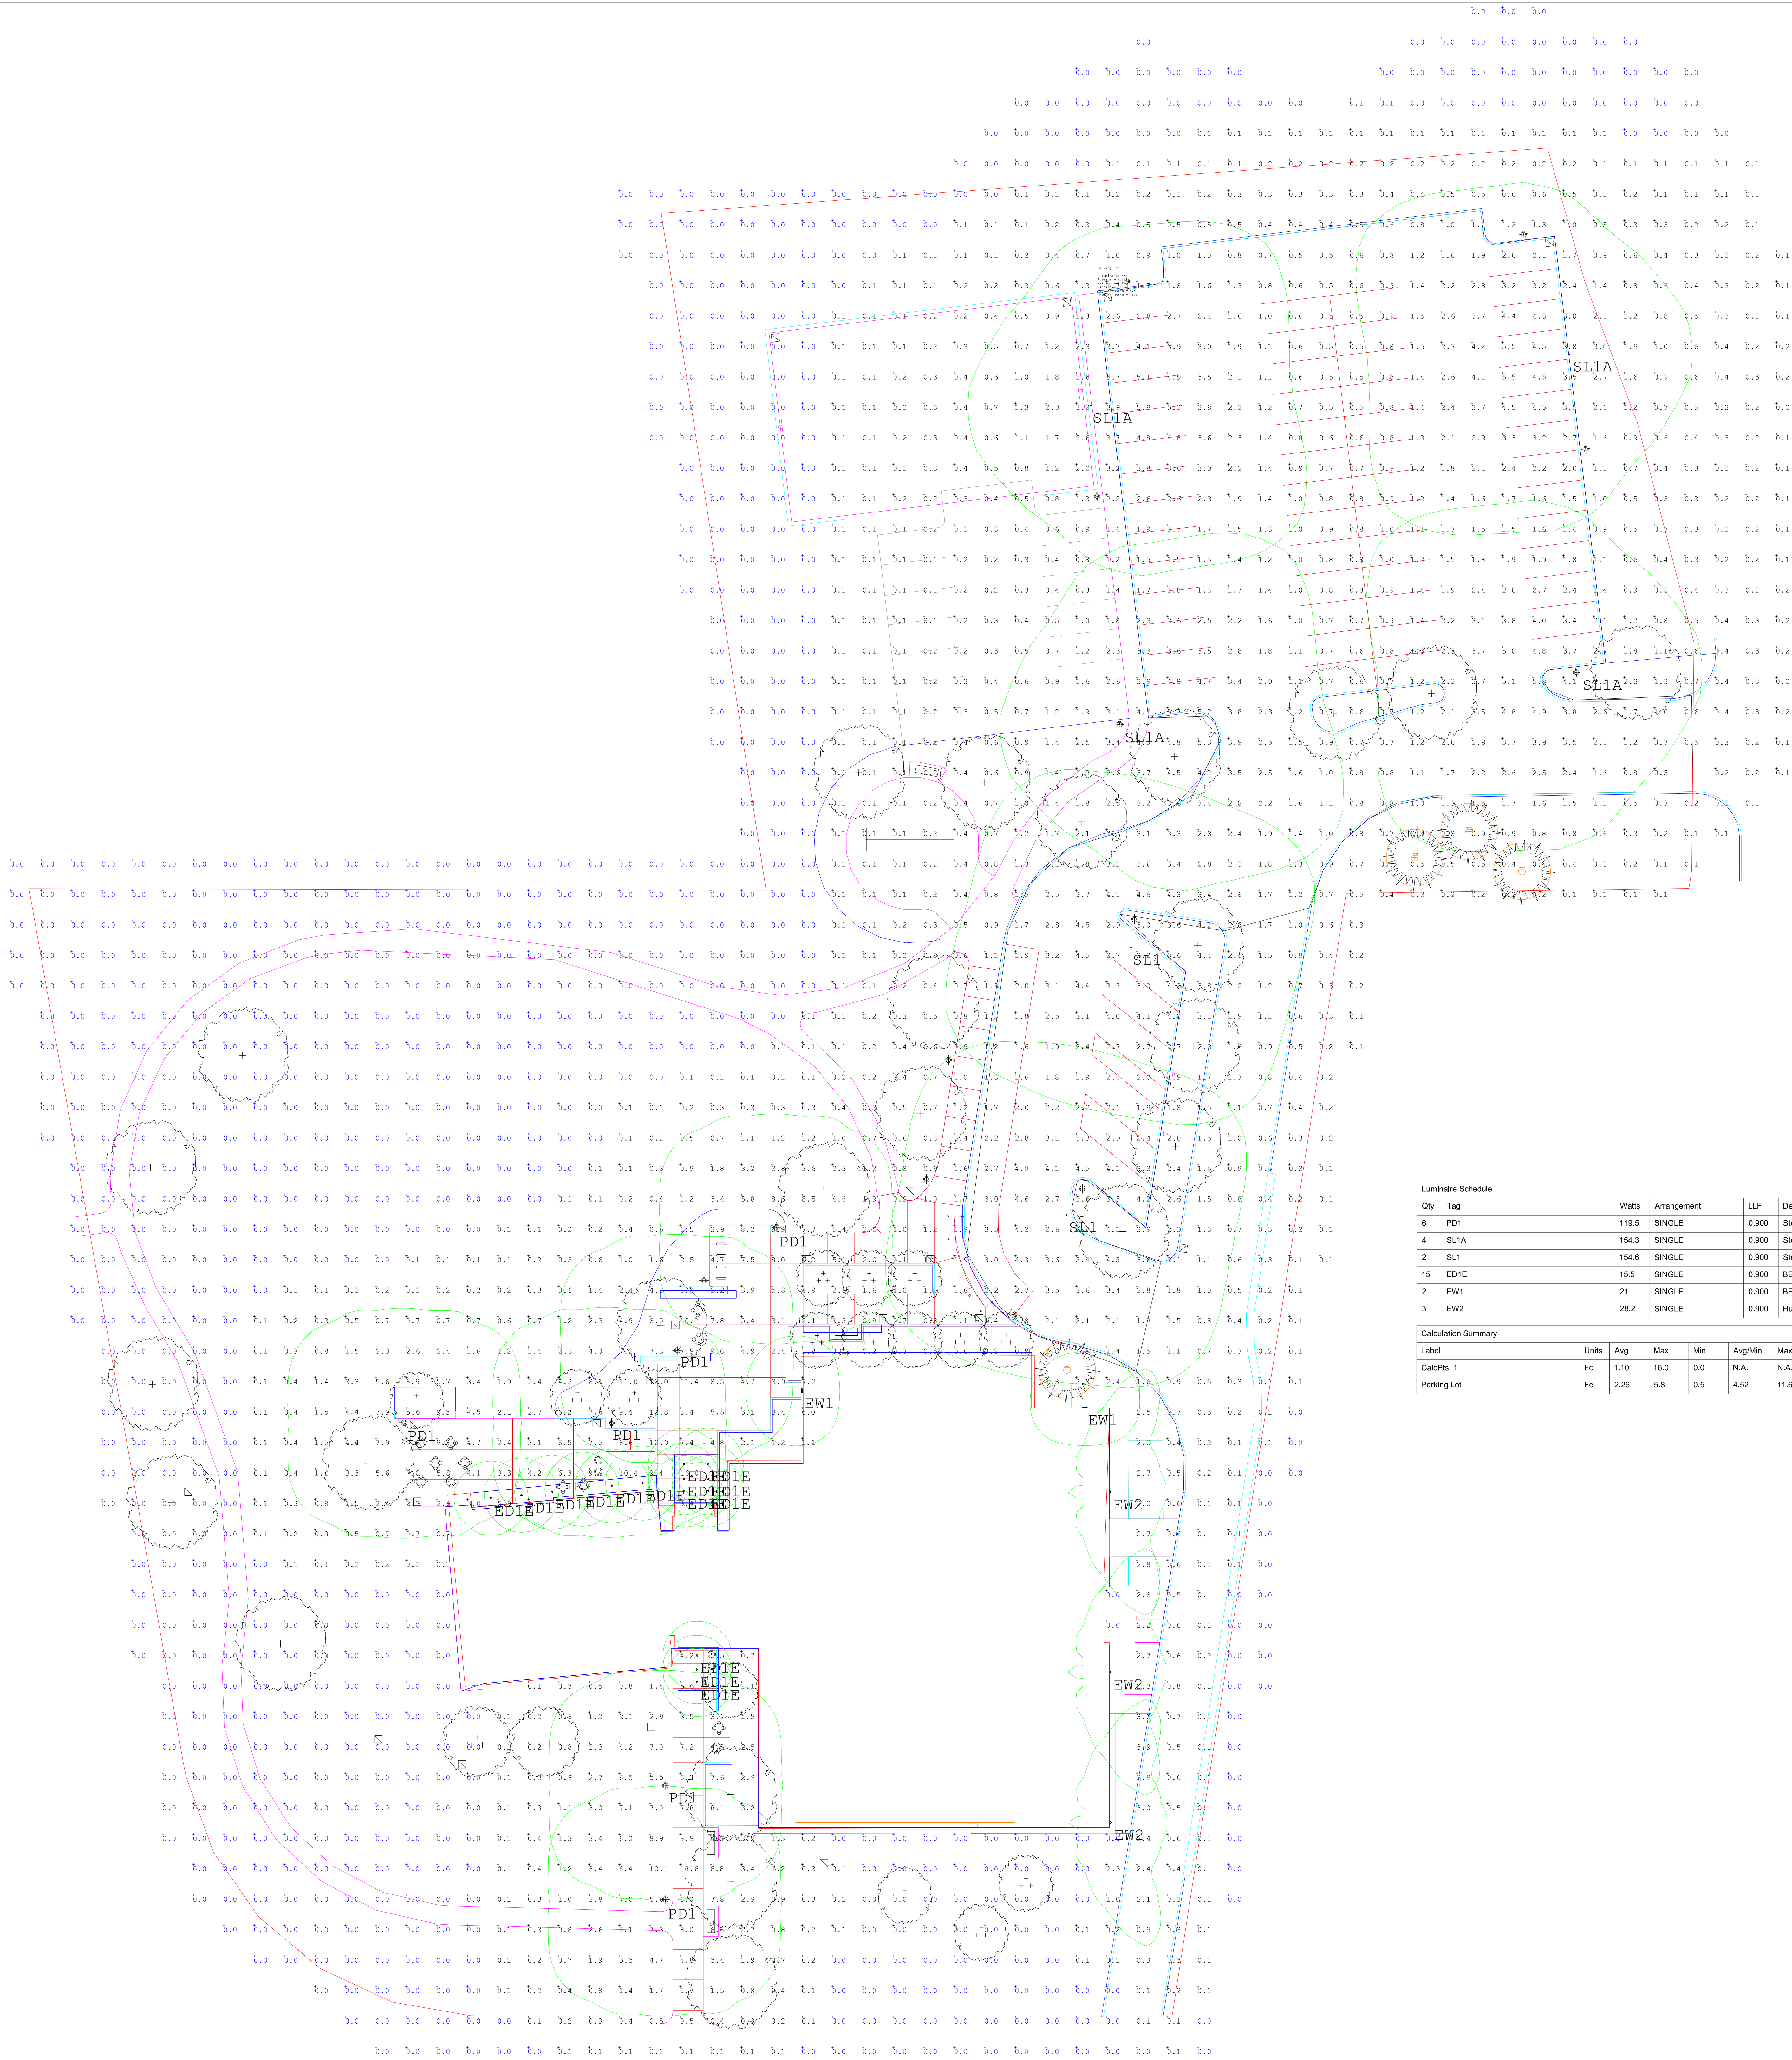

Luminaire Schedule				
Qty	Tag	Watts	Arrangement	LLF
6	PD1	119.5	SINGLE	0.900
4	SL1A	154.3	SINGLE	0.900
2	SL1	154.6	SINGLE	0.900
15	ED1E	15.5	SINGLE	0.900
3	EW1	21	SINGLE	0.900
3	EW2	28.2	SINGLE	0.900

Calculation Summary						
Label	Units	Avg	Max	Min	AvgMin	MaxMin
CalcPd1_1	Fc	1.10	16.0	0.0	N.A.	N.A.
Parking Lot	Fc	2.26	5.8	0.5	4.52	11.60

Project:
Dover CC

Contact:
Liza Tuttle
Specification Sales
(860) 751-4388
ltuttle@illuminate.com

Detail: Photometric Calculation
Date: 12-3-21
Revision: ----
Scale: N.T.S.
Drawn By: ----
Drawing Number:
illuminate
44 Sixth Road
Woburn, MA 01801
(781) 935-8500
333 Pleasant Valley Road
South Windsor, CT 06074
(860) 282-0597

L-1

Sheet 1 of 1